



PRODUCED BY AN AUTODESK EDUCATIONAL PRODUCT


PRODUCED BY AN AUTODESK EDUCATIONAL PRODUCT

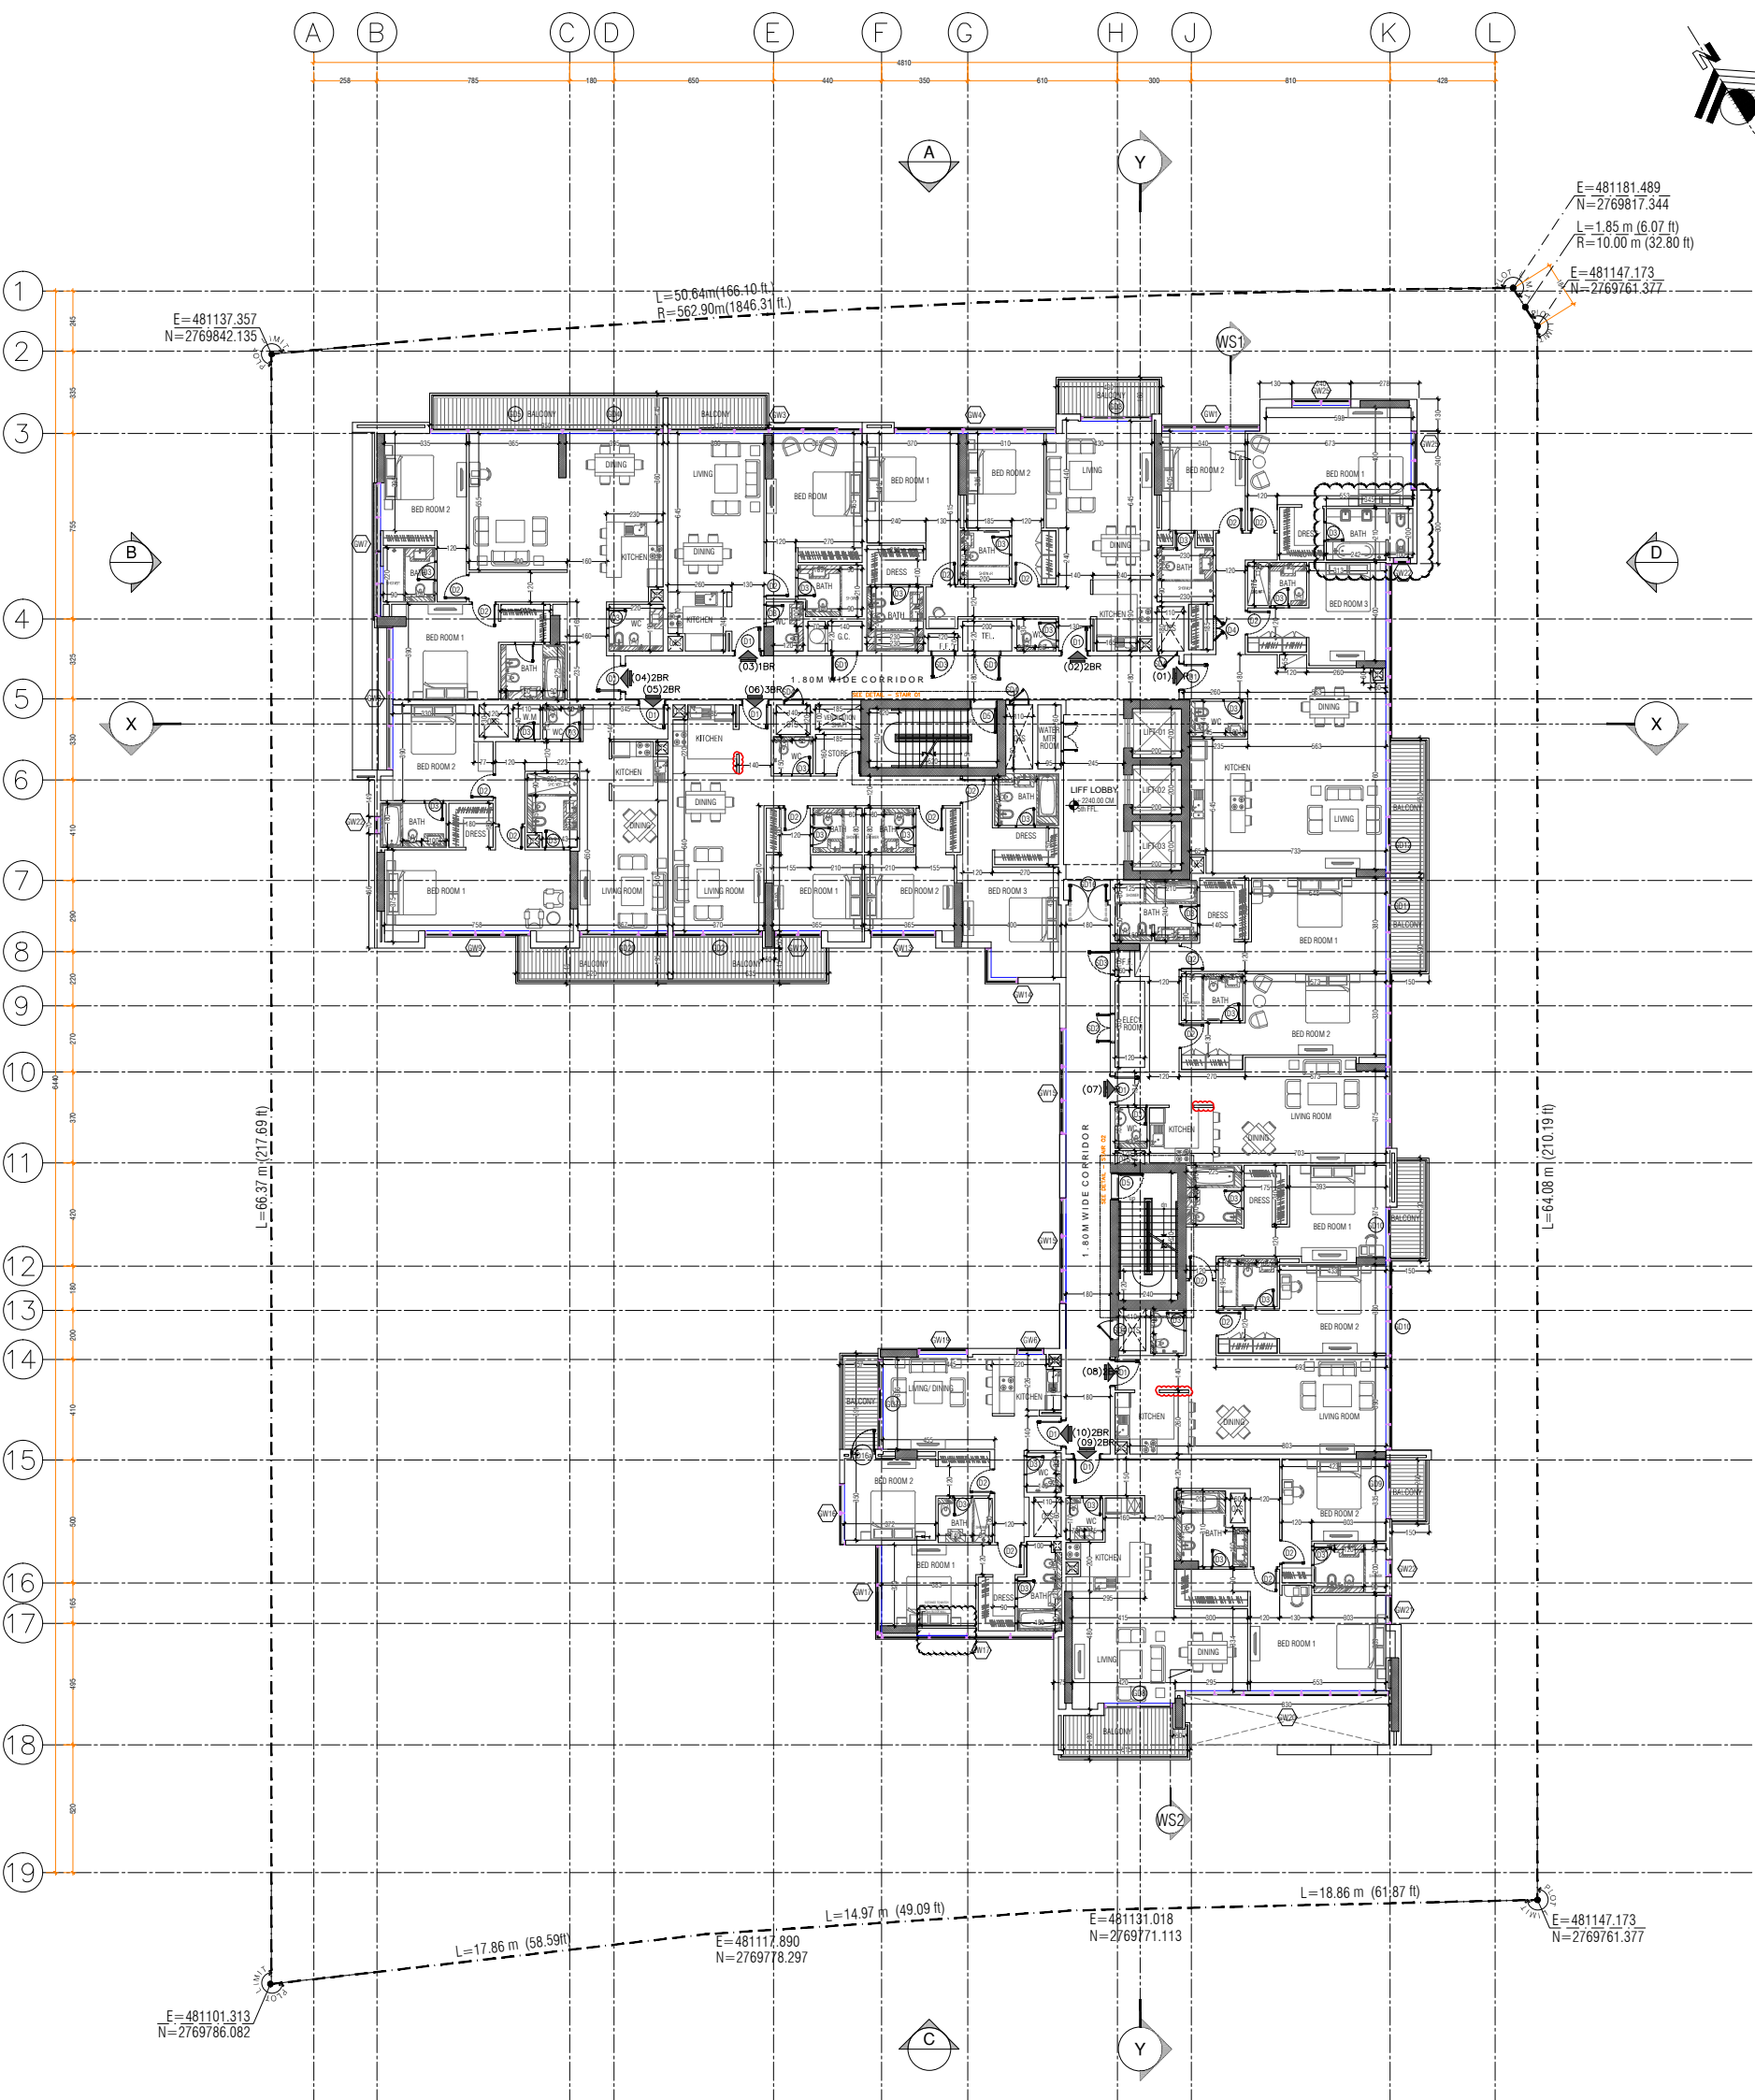

AS BUILT

Date Details of revision

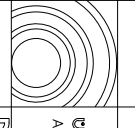
  
 DESIGN CENTER  
 ARCHITECTS AND ENGINEERS CONSULTANTS  
 P.O. BOX 88233, DUBAI, U.A.E. TEL: 971-4-3944433 FAX: 971-4-3944433

Contractor:  

  
 نارسكو للمقاولات (ل.م.ش.)  
 NARESCO CONTRACTING (L.L.C.)  
 Your search stops here  
 Tel: 3984545 Fax: 3984242 P.O. Box 6136, Dubai, UAE.  
 Email: naresco@emirates.net.ae Website: www.naresco.ae

PROJECT:	G+P+10 RESIDENTIAL BUILDING
CLIENT NAME:	ABDURAHMAN ABDULLA MOHD ALJAZIRI
PLOT NO.-AFRA 024 LOCATION:	AL FURJAN
DRAWN BY:	RAJINDER
SCALE:	N/S
DESIGNED BY:	DATE 07.04.2014
CHECKED BY:	JOB NO. 99
APPROVED BY:	
DWG. NO.:	A-107

DRWG. TITLE: 5TH. FLOOR PLAN  
 SHEET NO.: